


S/4824/18/VC – Site Plan

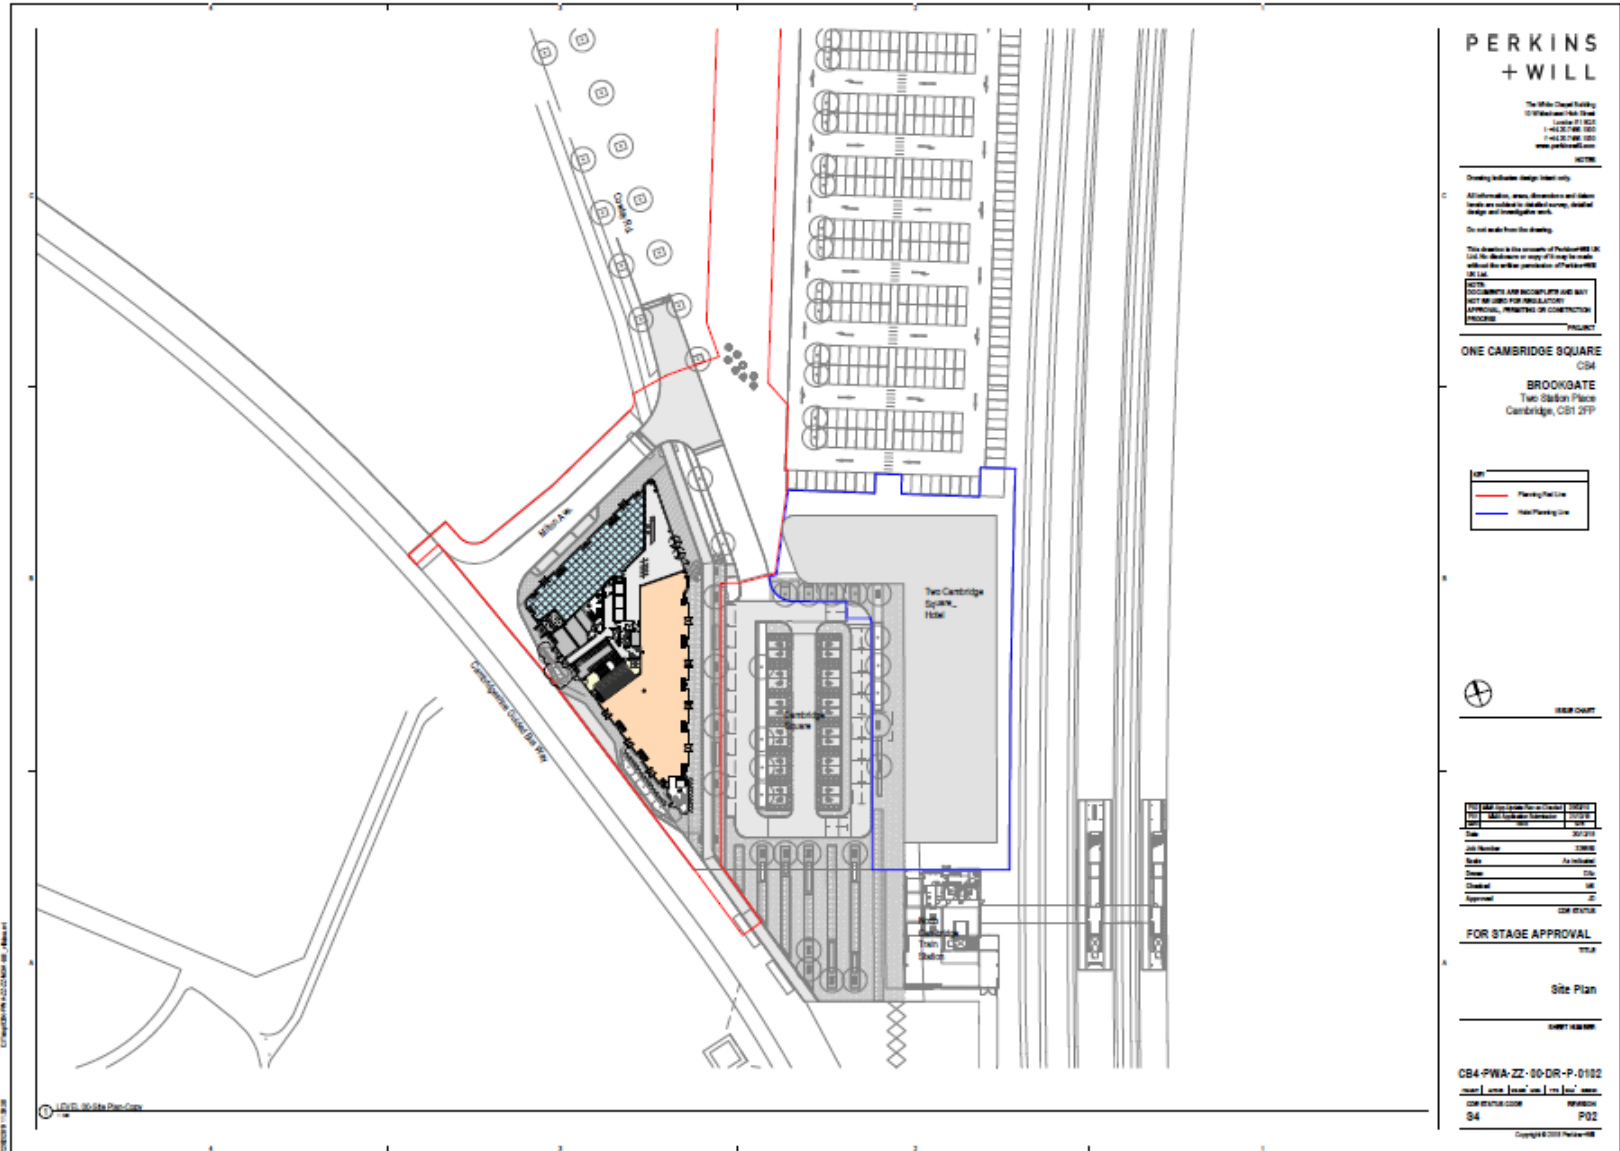

PERKINS + WILL

The White Chapel Building
 100 Water Street
 London EC4A 3DF
 T +44 (0)20 7596 9000
 F +44 (0)20 7596 9001
 www.perkinswill.com

Working for other design teams only.
 All information, views, observations and advice herein are subject to available surveys, detailed design and investigation work.
 Do not make from this drawing.

This drawing is the property of Perkins + Will Ltd. All the information on any of the drawings made without the written permission of Perkins + Will Ltd.

PERKINS + WILL
 SOLE AGENTS AND ARCHITECTS AND NOT NOT BE USED FOR ANY OTHER APPROVAL, PERMITS OR CONSTRUCTION PURPOSES

PROJECT
ONE CAMBRIDGE SQUARE
 CB4
 BROOKGATE
 Two, Station Place
 Cambridge, CB1 2PP

Line
—
—
—



REV	NO	DATE	DESCRIPTION	BY	CHK
1	1	2018/01/11	Issue for Stage Approval	SW	SW

Drawn: SW
 Checked: SW
 Approved: SW
 Date: 08/01/2018

FOR STAGE APPROVAL
 10/18

Site Plan
 SHEET NUMBER

CB4-PWA-ZZ-00-DR-P-0102
 Issue: Issue for Stage Approval
 Date: 08/01/2018
 S4
 P02
 Copyright © 2018 Perkins + Will