


- LEGEND**
- \*X\* - FIRE DOOR KEEP SHUT
  - SD - SMOKE DETECTOR
  - EXIT - ILLUMINATED EXIT SIGN
  - - BREAK GLASS POINT
  - SP - SOUNDER
  - - RADIATOR (POSITIONS TO BE CONFIRMED)

Client C D  
 Project 7 STARS, NEWMARKET ROAD, CAMBRIDGE  
 Drawing PUBLIC HOUSE FLOOR PLAN AS PROPOSED  
 Date Jan 18  
 Scale 1:50@A1  
 Dwg. No 13/1370/01 D

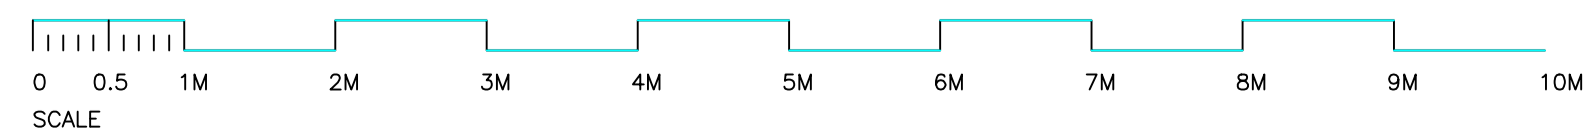

This drawing is copyright. Do not scale from this drawing.